


TONKAWATER™
A U.S. WATER BRAND

OptaCell Plus™ Pressure Filter System
End Piped Isolated - 2 Cell
Catalog Drawing

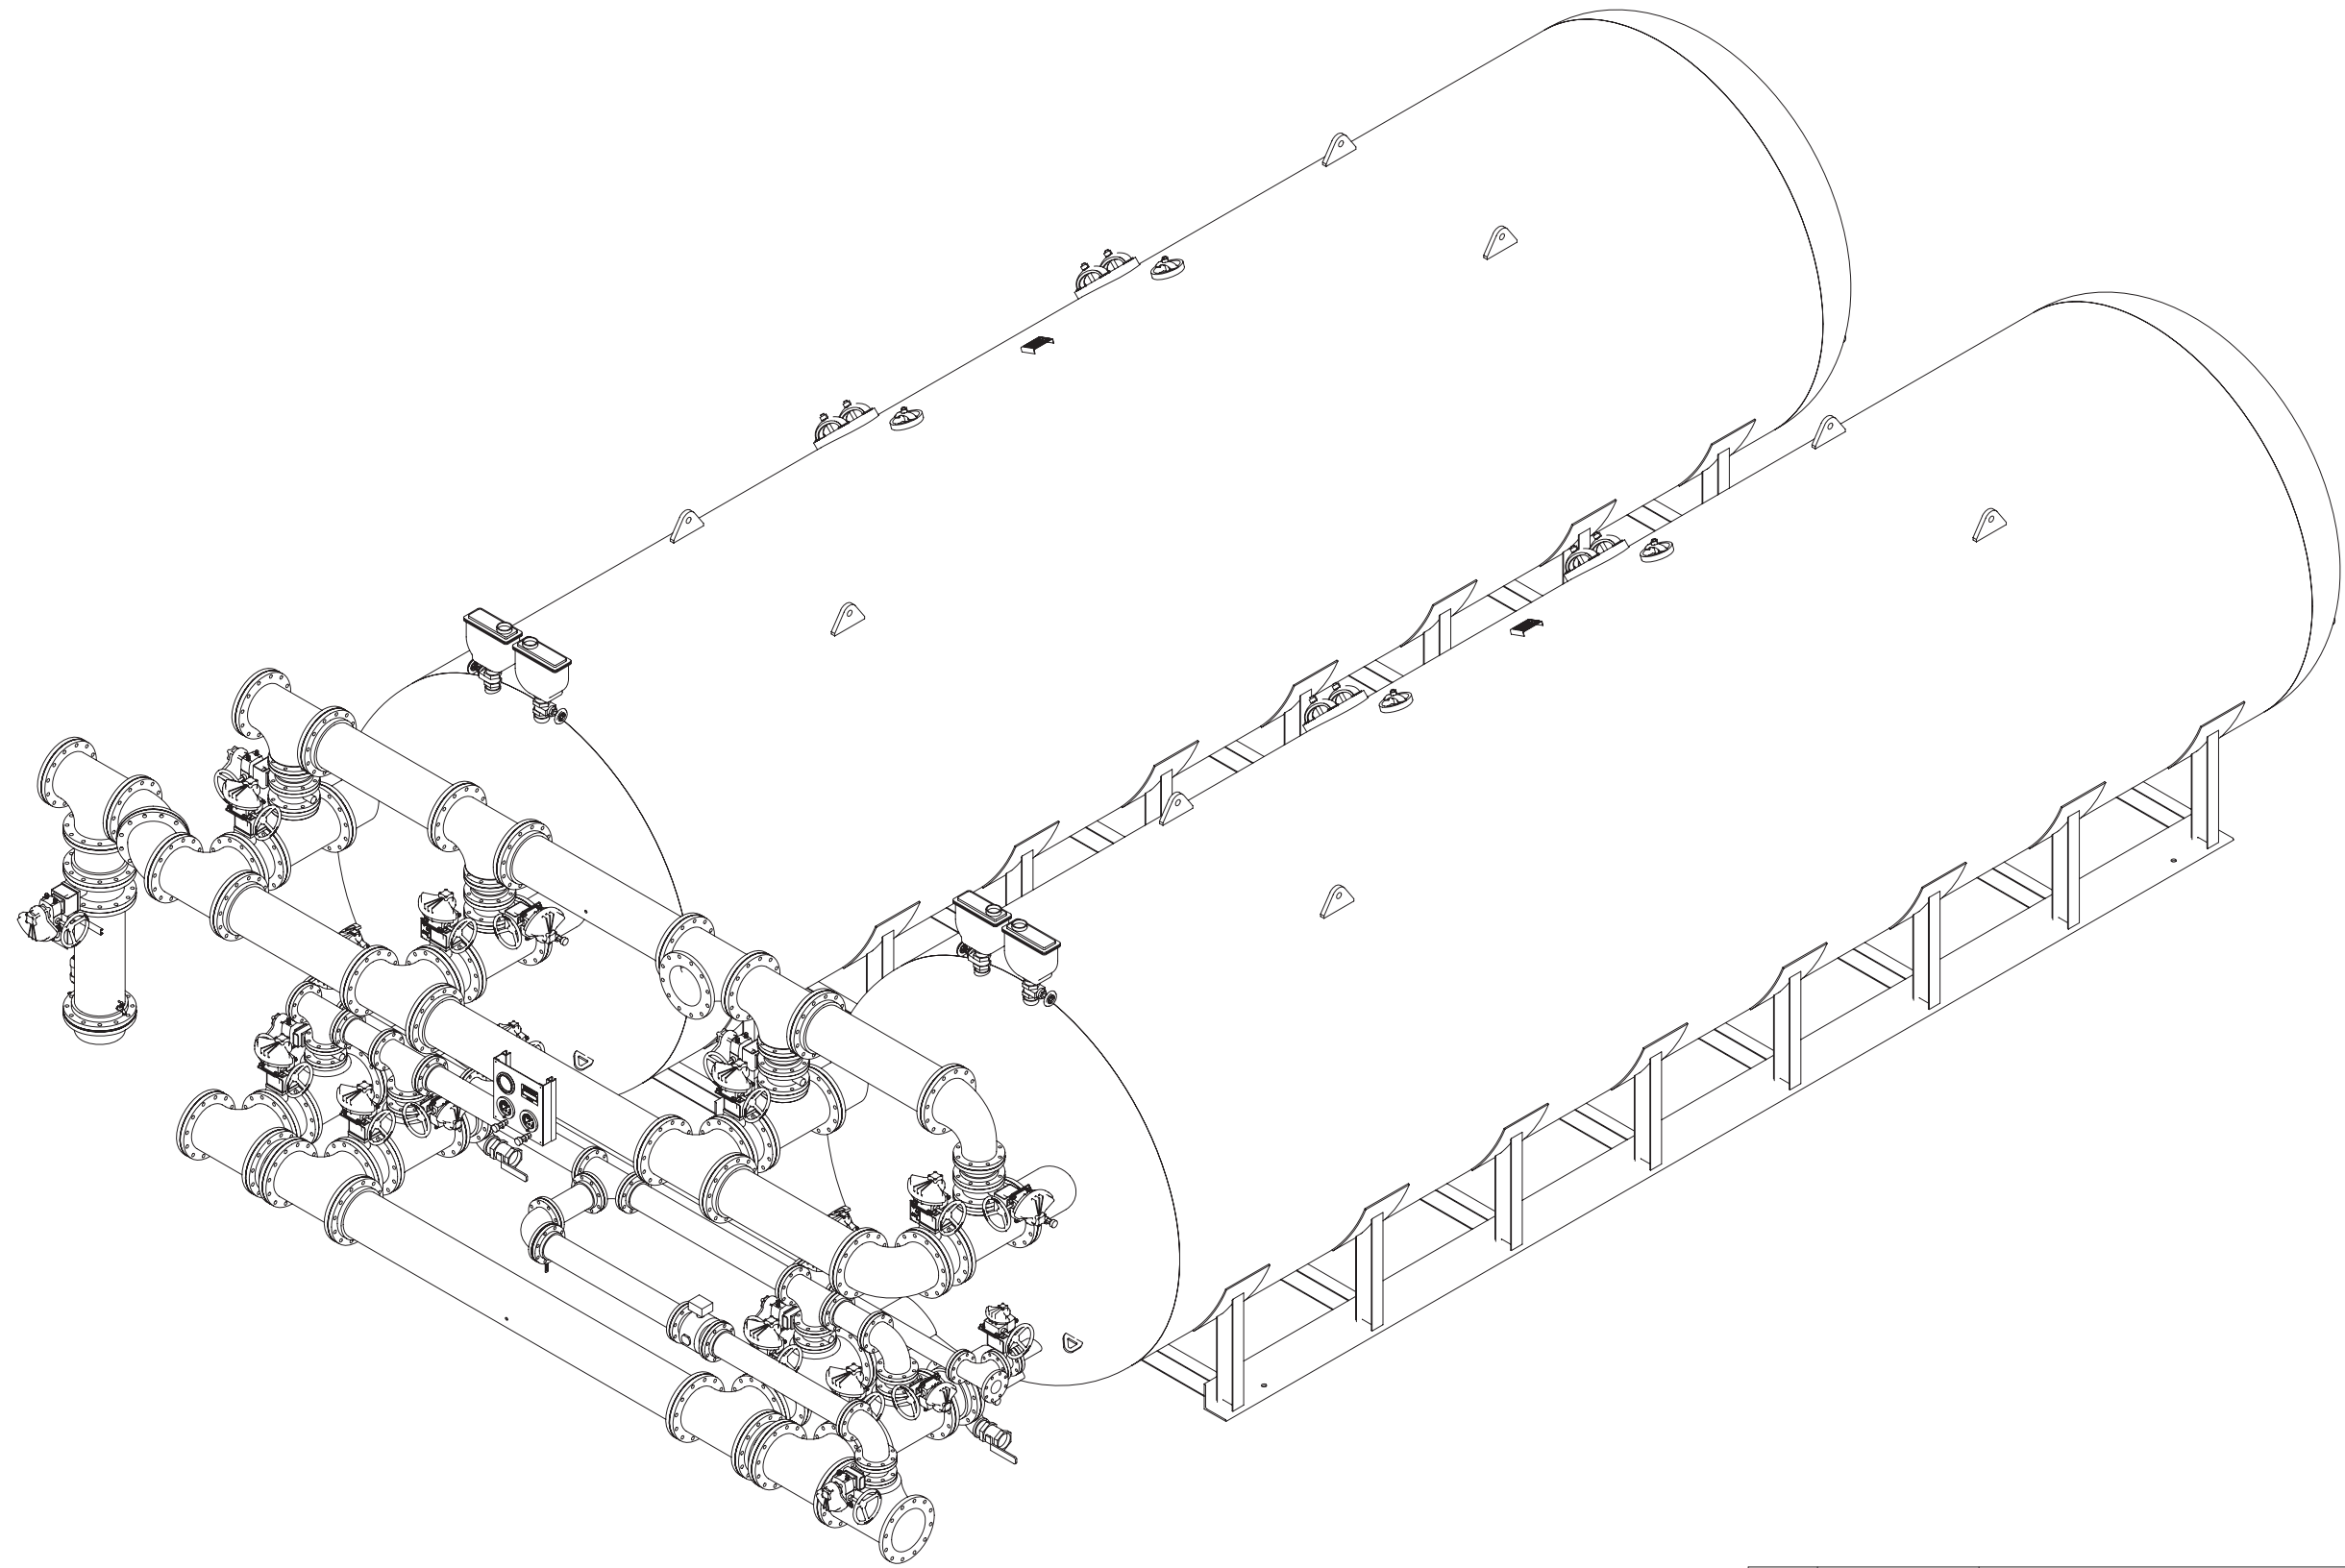

DRAWING SIZE: D				ALL RIGHTS TO MANUFACTURE, COPY, REPRODUCE OR DISPOSE OF THIS DRAWING OR ITS CONTENTS ARE RESERVED UNLESS OTHERWISE SPECIFIED IN WRITING BY TONKA EQUIPMENT COMPANY. DO NOT SCALE DRAWING			
DRAWN BY:	START DATE:	THICKNESS:		SHEET NUMBER:		REV:	
DDI	12/18/2013			1 OF 2		0	
DWG. SCALE:		LENGTH:		DRAWING NUMBER:			
1:24		300"		00064394			
APPR. BY:		APPROX. WEIGHT:					
		230640.906					


TONKAWATER™
A U.S. WATER BRAND

13305 WATERTOWER CIRCLE
PLYMOUTH, MN 55441
(763) 559-2837
www.tonkawater.com


OPTACELL PLUS™ PRESSURE FILTER SYSTEM
END PIPED ISOLATED - 2 CELL
CATALOG DRAWING

1 OF 2
0
00064394


Last Saved: Thursday, July 20, 2017 11:28:46 AM

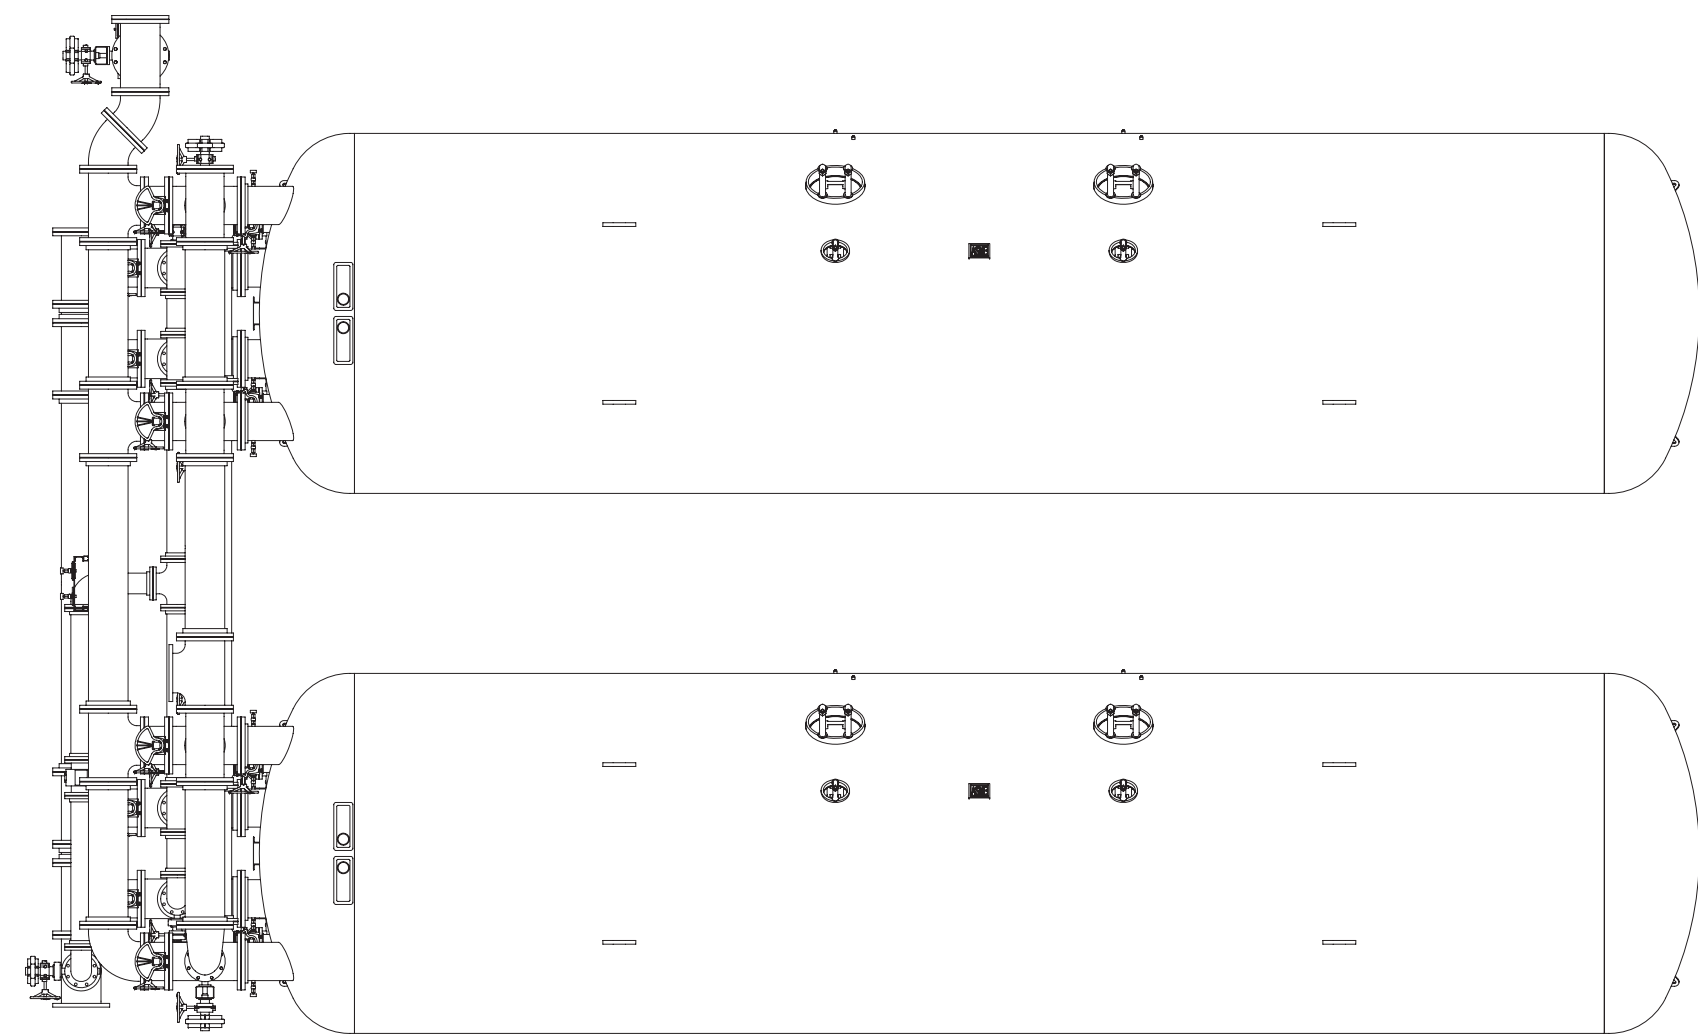

PLAN VIEW

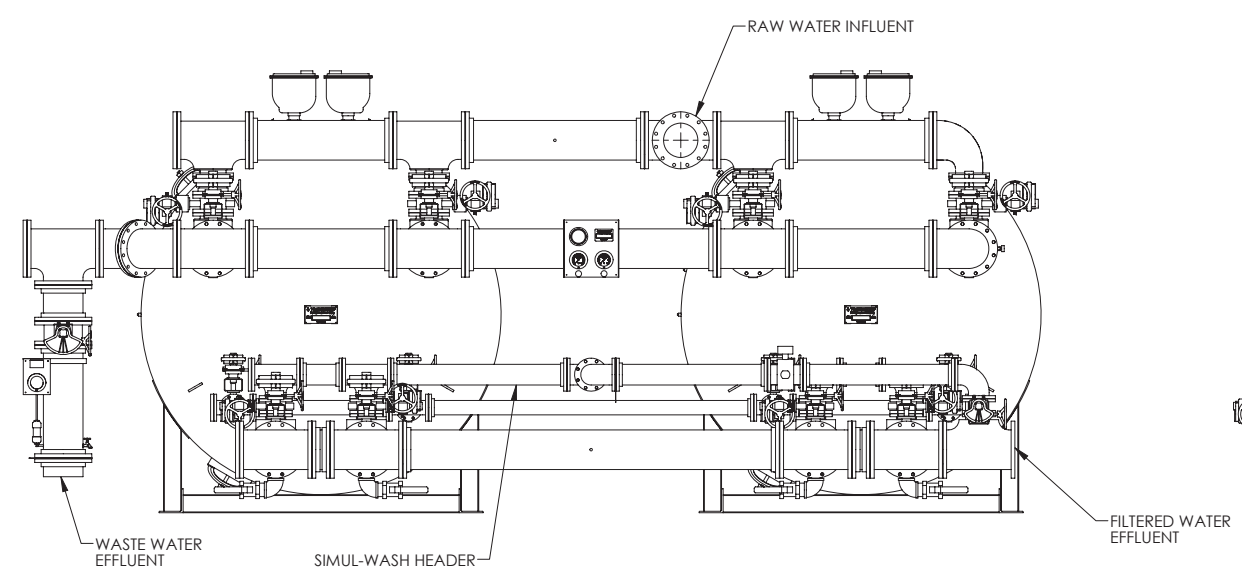

FRONT ELEVATION

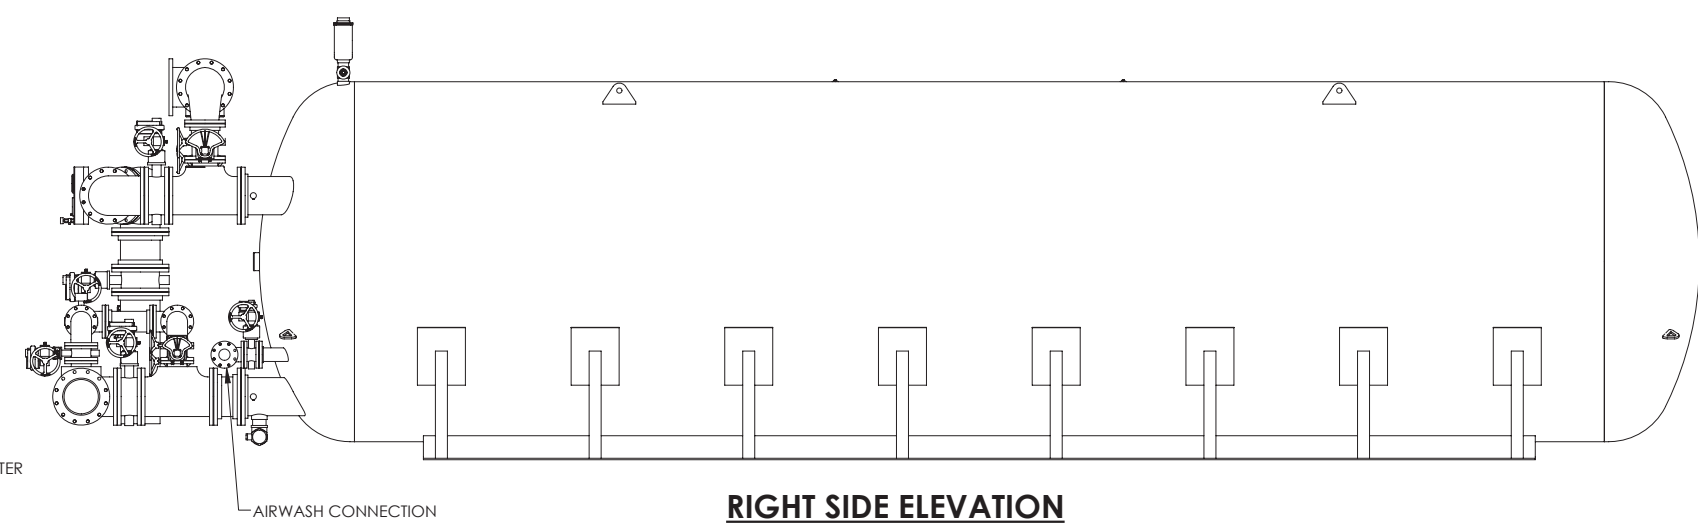

RIGHT SIDE ELEVATION

DRAWING SIZE: D		ALL RIGHTS TO MANUFACTURE, COPY, REPRODUCE OR DISPOSE OF THIS DRAWING OR ITS CONTENTS ARE RESERVED UNLESS OTHERWISE SPECIFIED IN WRITING BY TONKA EQUIPMENT COMPANY.	
DRAWN BY: DDI	START DATE: 12/18/2013	THICKNESS:	
	DWG. SCALE: 1:32	LENGTH: 300"	
	APPR. DATE:	APPROX. WEIGHT: 230640.906	

TONKAWATER
A U.S. WATER BRAND

13305 WATERTOWER CIRCLE
PLYMOUTH, MN 55441
(763) 559-2837
www.tonkawater.com

**OPTACELL PLUS™ PRESSURE FILTER SYSTEM
END PIPED ISOLATED - 2 CELL
CATALOG DRAWING**

SHEET NUMBER: **2 OF 2**
REV: **0**
DRAWING NUMBER: **00064394**

Last Saved: Thursday, July 20, 2017 11:28:46 AM